

FIRST FLOOR

SCALE: 1/4" = 1'-0"

DOOR SCHEDULE

QUANTITY	DOOR			FRAME			REMARKS	
	TYPE	WIDTH	HEIGHT	HARDWARE	TYPE	HEAD		JAMB
1	1	5'-11 1/4"	6'-8"	NOTE 3	WOOD	WOOD	WOOD	PERMA-SHIELD GLIDING PATIO DOOR (MODEL # P651168L)
1	2	3'-0"	6'-8"	NOTE 3	WOOD	WOOD	WOOD	THERMA-TRU FIBERGLASS ENTRY DOOR
1	3	2'-6"	6'-8"	NOTE 3	WOOD	WOOD	WOOD	6 RAISED PANEL INTERIOR DOOR
1	4	2'-4"	6'-8"	NOTE 3	WOOD	WOOD	WOOD	6 RAISED PANEL INTERIOR DOOR
1	5	2'-0"	6'-8"	NOTE 3	WOOD	WOOD	WOOD	6 RAISED PANEL INTERIOR BI-FOLD DOOR
2	6	4'-0"	6'-8"	NOTE 3	WOOD	WOOD	WOOD	6 RAISED PANEL INTERIOR BI-FOLD DOOR

NOTES:

- ALL DIMENSIONS SHOWN ARE UNIT DIMENSIONS. ROUGH OPENINGS ON EXTERIOR UNITS MAY NEED TO BE ADJUSTED TO ALLOW FOR FLASHING, SILL PANNING, BRACKETS, FASTENERS OR OTHER ITEMS. VERIFY EXACT DIMENSIONS IN FIELD.
- ALL INTERIOR DOORS TO BE HOLLOW MASONITE DOORS (UNLESS OTHERWISE NOTED AND/OR SPECIFIED BY OWNER).
- ALL DOOR HARDWARE TO BE SELECTED BY OWNER AND SUPPLIED & INSTALLED BY CONTRACTOR.
- EXACT STYLE AND MODEL OF ALL DOORS TO BE SELECTED BY OWNER AND SUPPLIED & INSTALLED BY CONTRACTOR.
- PATIO DOOR (TYPE 1) TO BE ANDERSON PERMA-SHIELD GLIDING UNIT.
- DENOTES DOOR SYMBOL.
- ALL EXTERIOR DOOR HEADERS TO BE (3) 2X10.



ELECTRICAL LEGEND		
ELECTRICAL	COUNT	SYMBOL
co detector	2	⊙
fan	1	⊕
smoke detector	2	⊛

WINDOW SCHEDULE

NO.	SYMBOL	MODEL #	ROUGH OPENING	STYLE	GLAZING AREA
4	A	244DH4040	3'-0" X 4'-0"	TILT-WASH DOUBLE HUNG	8.0 SQ. FT.
1	B	244DH2030	2'-0" X 3'-0"	TILT-WASH DOUBLE HUNG	3.3 SQ. FT.
1	C	244DH3030	3'-0" X 3'-0"	TILT-WASH DOUBLE HUNG	5.6 SQ. FT.
2	D	TW24310-2	4'-11 15/16" X 4'-1 1/4"	DOUBLE WIDE TILT-WASH COMBINATION	14 SQ. FT.

NOTES:

- ALL WINDOWS TO BE ANDEREN 200 SERIES (UNLESS OTHERWISE NOTED).
- ALL UNITS TO BE DOUBLE PANE W/LOW-E GLAZING.
- ALL HEADERS TO BE (3) 2X10 (UNLESS OTHERWISE NOTED).
- DENOTES WINDOW SYMBOL.

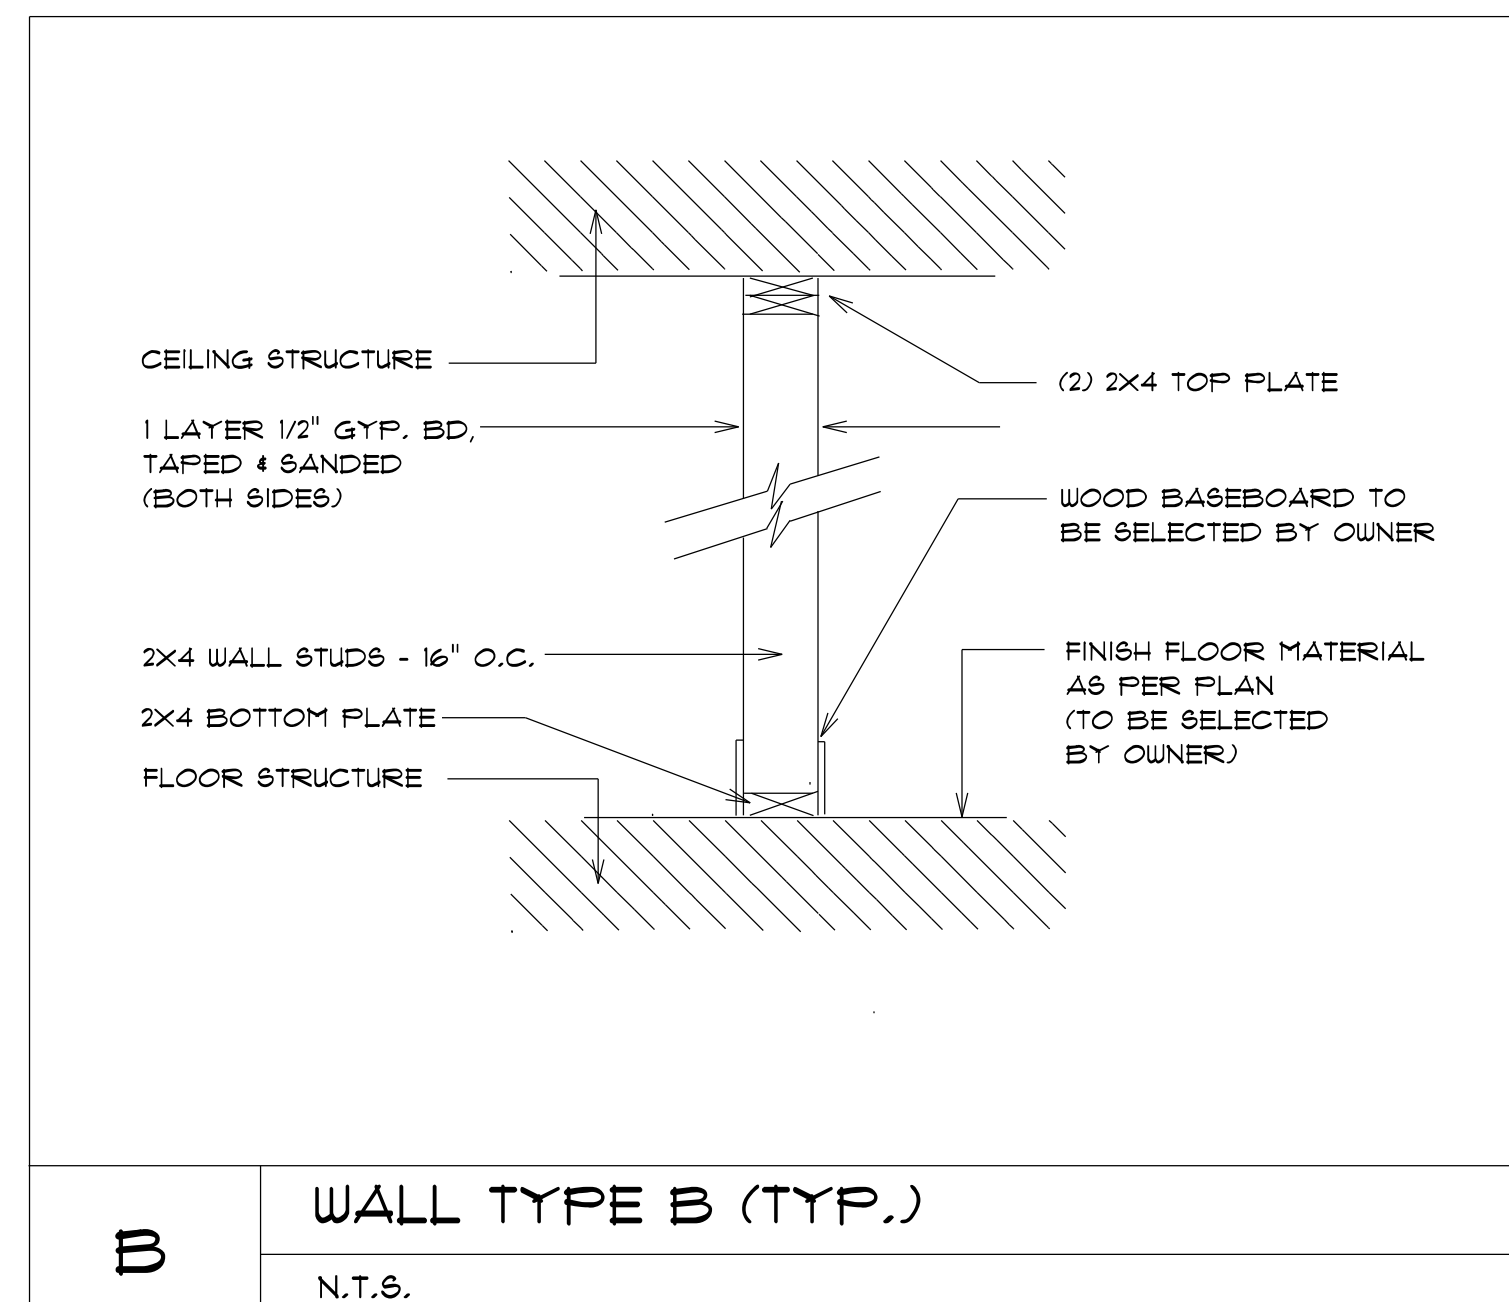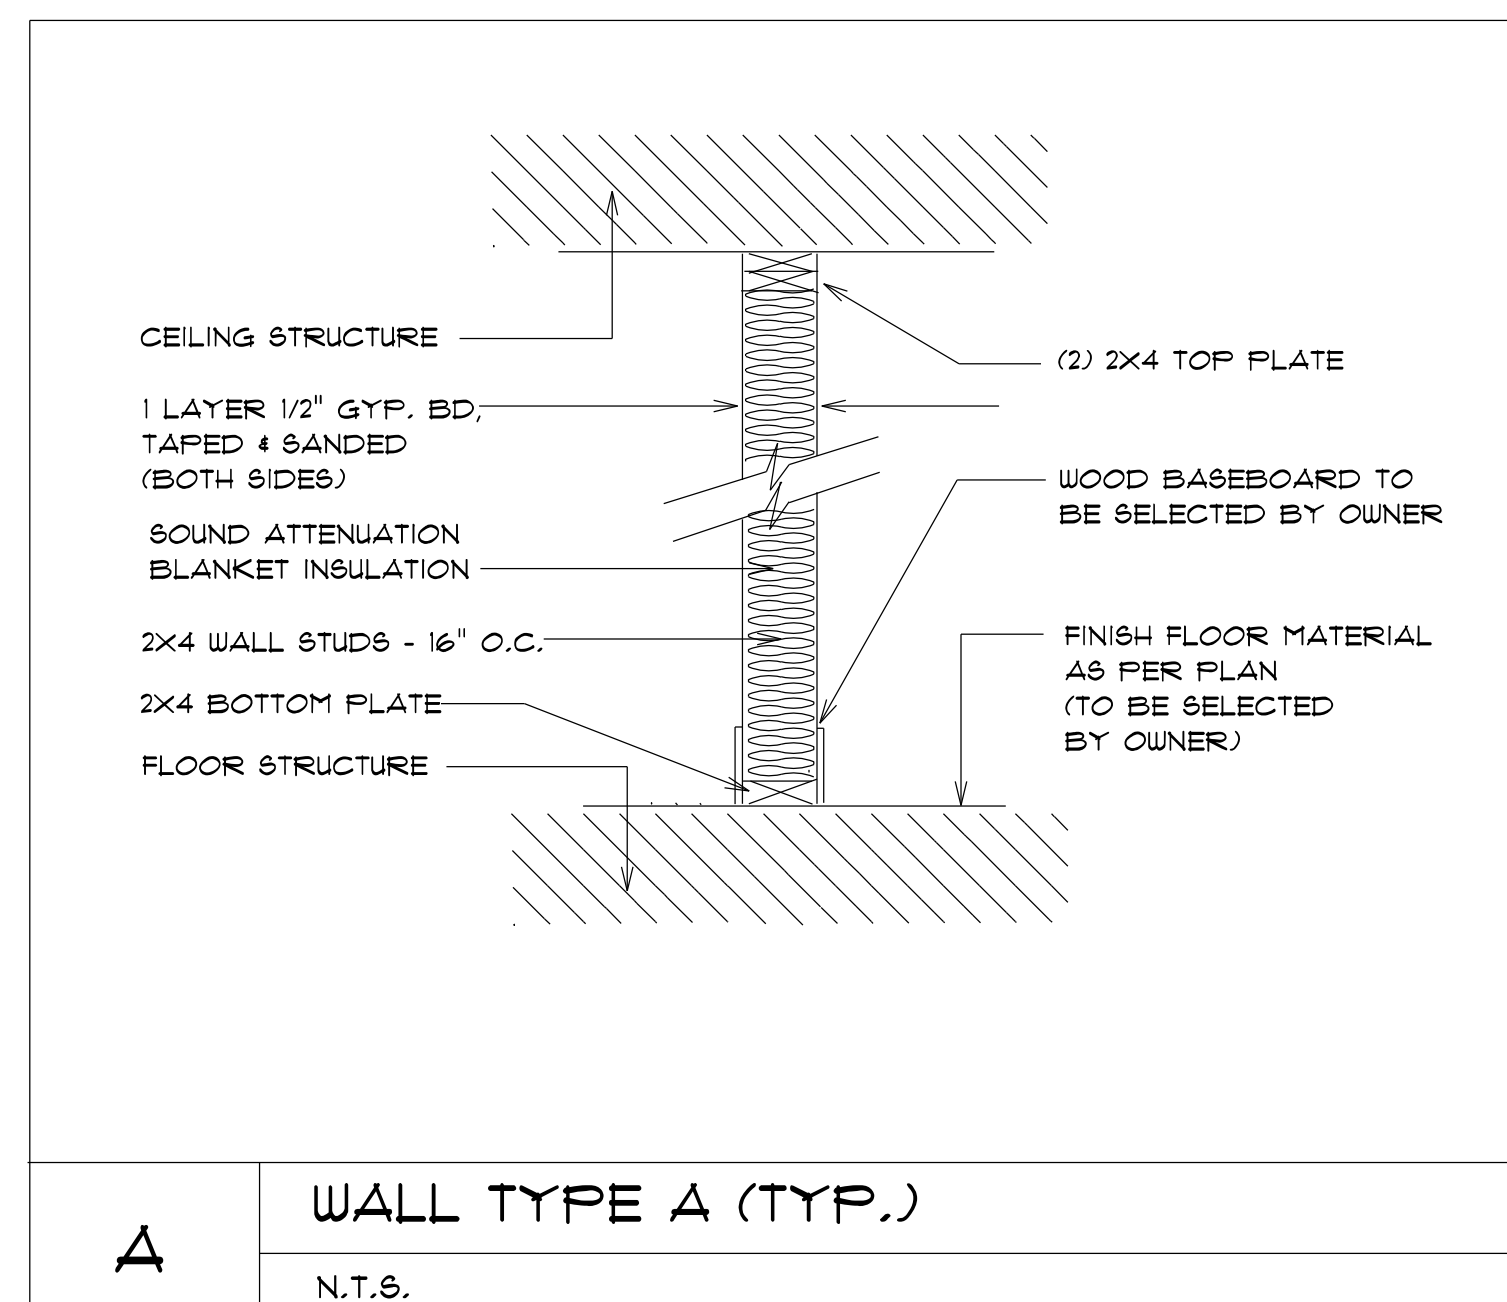

DATE: FEBRUARY 26, 2019

SCALE: AS SHOWN

DRAWN BY: PFM

REVISIONS:

VISION DESIGN & CONSTRUCTION, INC.
14 WESTERN AVENUE
WAKEFIELD, MA
(781) 844-8645

SINGLE FAMILY DWELLING
45 LAKEVIEW AVENUE
LYNNFIELD, MA

FIRST FLOOR PLAN

A - 103