


FURNITURE & EQUIPMENT/POWER PLAN
SCALE: 1/4" = 1'-0"

PROJECT:
COMMERCIAL FIT-OUT
SERVIZIO CORP.; ATTN: GUY CIOLFI
525 MARKET STREET
LYNNFIELD, MA 01940

PROJECT NUMBER: 22033

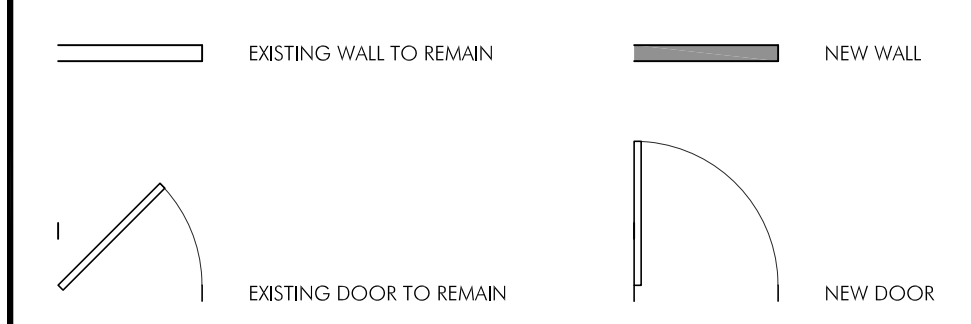

FLOOR PLAN LEGEND
NOT TO SCALE


- POWER PLAN NOTES - SPECIFIC**
(NOTES ARE KEYED ON DRAWINGS)
- 1 N/A
 - 2 N/A
 - 3 N/A
 - 4 208-230/60/1
 - 5 115/60/20A
 - 6 115/60/1 15A
 - 7 115/60/1 20A
 - 8 BOTTOM: 3/2" PRESSURE-5 WC X2
TOP: 3/2" PRESSURE-5 WC
 - 9 GAS SUPPLY PRESSURE 7.10" w.c. (17.4 mbar/1.7 kPa)
BURNER MANIFOLD PRESSURE 4" w.c. (10 mbar/1 kPa)
115V/208/220-240V
 - 10 WATER AND FLOOR DRAIN; 115/60/1; 115/60/1 20A (ICE)
 - 11 208-240/60/1
 - 12 115/60/1 15A
 - 13 115/60/1 15A
 - 14 N/A
 - 15 120V/60/1 15A
 - 16 208-230/60/1
 - 17 EVAPORATOR - 115/60/1
COMPRESSOR - 208-230V
 - 18 EXHAUST FAN 460V - 3 PHASE
HEATER - 460V/60/3 PHASE
COOLING - 460V/3 PHASE

POWER PLAN KEYED NOTES

- FLOOR PLAN NOTES - SPECIFIC**
(NOTES ARE KEYED ON DRAWINGS)
- 1 BOOTHS TO BE RELOCATED BY G.C. / OWNER; COORDINATE LOCATION WITH OWNER
 - 2 OWNER PROVIDED TRASH/RECYCLING BINS
 - 3 OWNER PROVIDED 12'-0" COMMUNITY TABLE AND CHAIRS
 - 4 OWNER PROVIDED 18 1/2" X 32 1/4" TAYLOR C709 SOFT SERVE FREEZER
 - 5 OWNER PROVIDED 52" X 34 3/4" X 24 7/8" TRUE REFRIGERATION TRUE DRAFT REFRIGERATOR TERS2-RE21-L-B-SG-1
 - 6 OWNER PROVIDED TRUE 30"X60" UNDER-COUNTER FRIDGE TUC-60-4HC
 - 7 OWNER PROVIDED TRUE 93" MIGHTY TOP SANDWICH UNIT REFRIGERATOR WITH DRAWERS RA93N24M-D
 - 8 OWNER PROVIDED 60" RADIANCE RESTAURANT RANGE TARG-2B4BG AND TASM-36 SALAMANDER BROILER
 - 9 OWNER PROVIDED 18" X 18" PITCO SOUSTICE SUPREME SSH SERIES GAS FRYER; (3) SSH75
 - 10 OWNER PROVIDED COUNTERTOP BEVERAGE STATION W/ TOP MOUNT ICE MAKER 33" X 33" W X 64" H
 - 11 OWNER PROVIDED HOBART 16H HOT UNDER-COUNTER DISHWASHER
 - 12 OWNER PROVIDED 27 1/2" X 33 3/2" TRUE SPEC SERIES REACH-IN REFRIGERATOR W/ HYDROCARBON REFRIGERANT
 - 13 OWNER PROVIDED TRUE UNDER-COUNTER FREEZER TUC-27F-HC
 - 14 OWNER PROVIDED ADVANCE TABCO ALUMINUM SHEET PAN RACK PR20-3W
 - 15 OWNER PROVIDED 13 1/2" X 14 3/2" ROBOT COUPE FOOD PROCESSOR
 - 16 OWNER PROVIDED MASTERBUILT 8' X 8' WALK-IN FREEZER W/ SELF-CONTAINED REFRIGERATION SYSTEM
 - 17 OWNER PROVIDED NORLAK 6' X 8' WALK-IN REFRIGERATOR W/ RSG MHV1D012RC CONDENSING UNIT
 - 18 OWNER PROVIDED CAPTIVEAIR 13'-0" WALL CANOPY HOOD

FLOOR PLAN KEYED NOTES

STAMP:

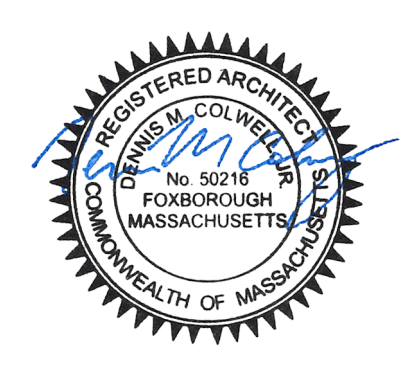

ISSUE:	DATE:
ISSUE FOR PERMIT	04.22.2022

DRAWING SCALE:	1/4" = 1'-0"
DRAWN BY:	MEH
CHECKED BY:	DMC

DRAWING TITLE:
FLOOR PLAN

DRAWING NUMBER:

A1.1